



POLISHED BACKPLATE
COLOR TBD

POLISHED ORB NUT
COLOR TBD

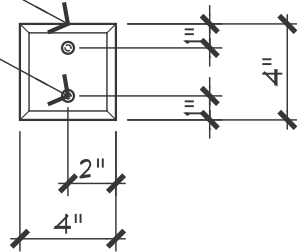

BACKPLATE ELEVATION

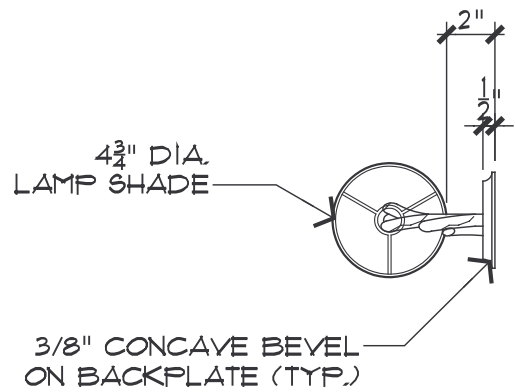


PLAN VIEW

CAST ALUMINUM ARM
COLOR TBD

PARCHMENT PERMAMOUNT
SHADE - COLOR TBD

1/8" BRASS STRIPS & EDGE
BASKET WEAVE PATTERN
COLOR TBD

40 WATT CANDELABRA BASE
FROSTED TORPRDO TIP

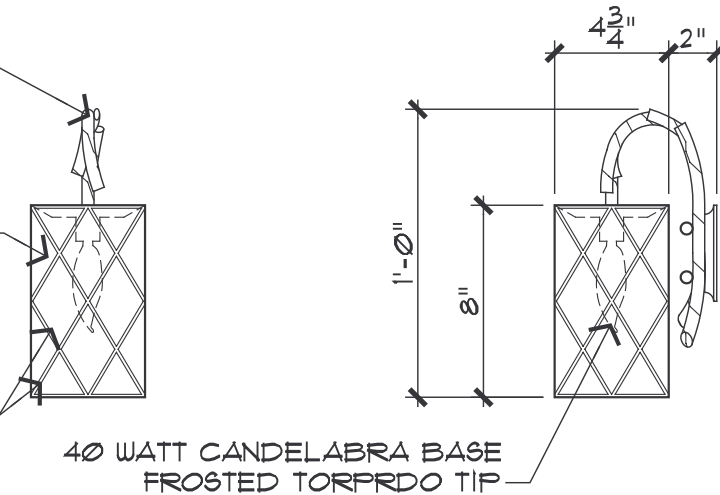

FRONT ELEVATION

SIDE ELEVATION

1 SMALL WALL SCONCE

SCALE: 1-1/2" = 1'-0"

xxx1.dwg

THIS DESIGN IS THE PROPERTY OF WYNN DESIGN AND DEVELOPMENT, IT MAY NOT BE REPRODUCED, DUPLICATED OR SOLD WITHOUT WRITTEN PERMISSION OF THE OWNER.

DRAWING NUMBER:

1 OF 2

PROJECT NUMBER:

TBD

REVIEWED BY:

DSA

DATE:

6-6-2006

PROJECT:

ENCORE PHONE BOOTH LIGHTING


DRAWING TITLE:

WALL MOUNTED SCONCE LIGHT


CUSTOM DESIGN BY ROGER THOMAS




680 Pilot Road, suite 1
Las Vegas, Nevada 89119
PHONE: (702) 770-5000
FAX: (702) 770-5003

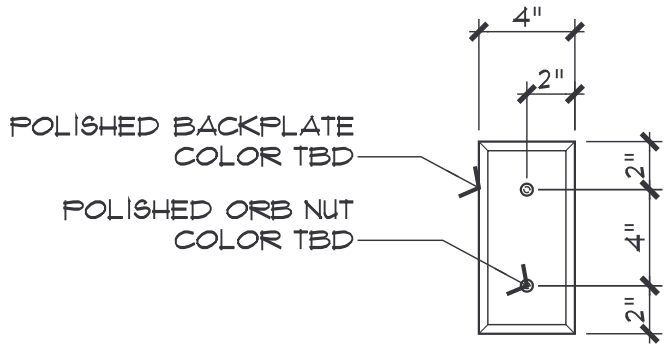


BACKPLATE ELEVATION

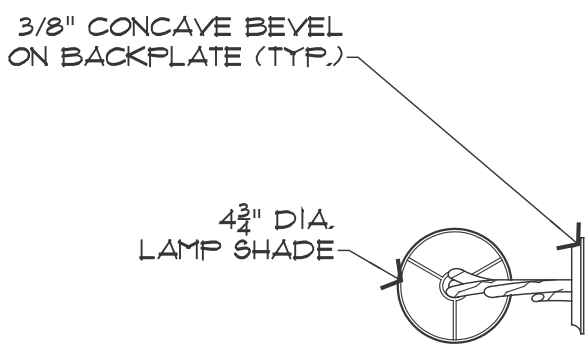

PLAN VIEW

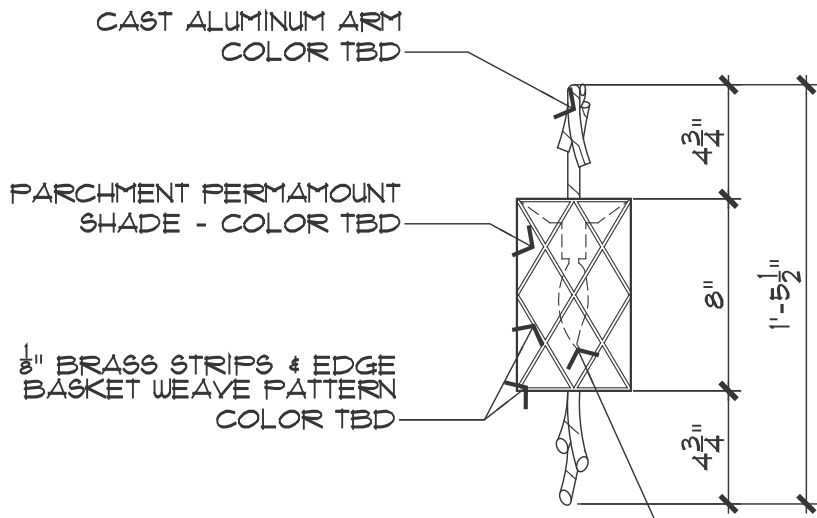

FRONT ELEVATION

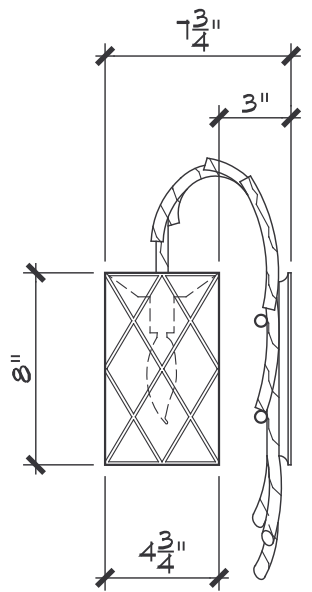


SIDE ELEVATION

40 WATT CANDELABRA BASE
FROSTED TORPRDO TIP


2 **LARGE WALL SCONCE**
SCALE: 1-1/2" = 1'-0" xxx1.dwg

THIS DESIGN IS THE PROPERTY OF WYNN DESIGN AND DEVELOPMENT, IT MAY NOT BE REPRODUCED, DUPLICATED OR SOLD WITHOUT WRITTEN PERMISSION OF THE OWNER.


DRAWING NUMBER: 2 OF 2	PROJECT NUMBER: TBD	PROJECT: ENCORE PHONE BOOTH LIGHTING	
	REVIEWED BY: DSA	DRAWING TITLE: WALL MOUNTED SCONCE LIGHT	<div style="border: 1px solid black; width: 100px; height: 30px; margin-bottom: 5px;"></div> 680 Pilot Road, suite 1 Las Vegas, Nevada 89119 PHONE: (702) 770-5000 FAX: (702) 770-5003
	DATE: 6-6-2006	CUSTOM DESIGN BY ROGER THOMAS	

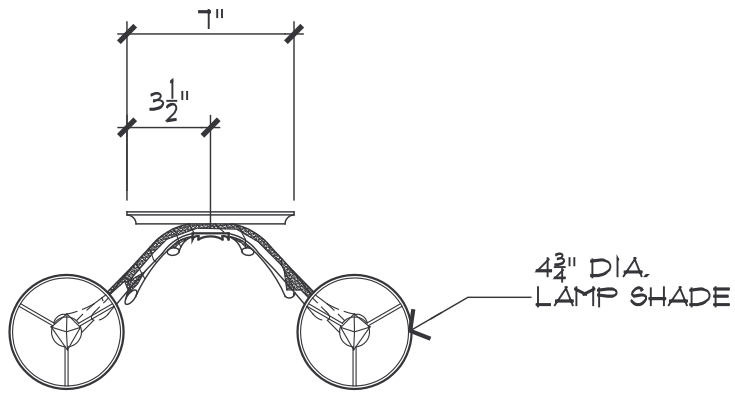

PLAN VIEW

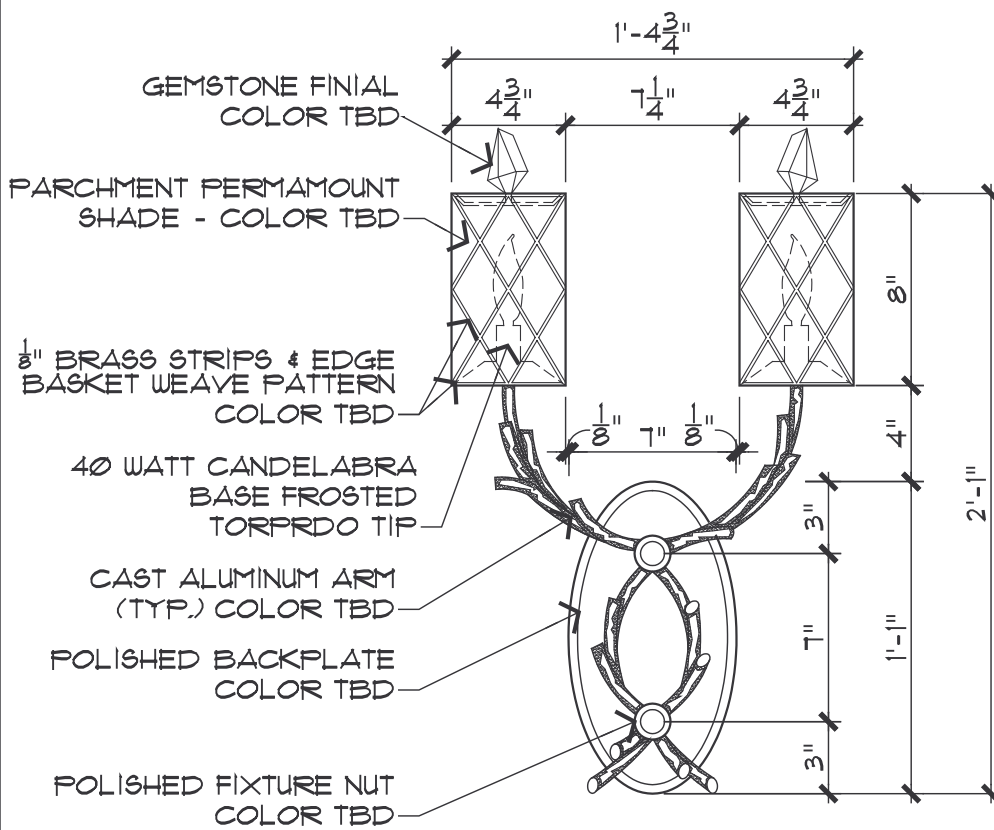

FRONT ELEVATION

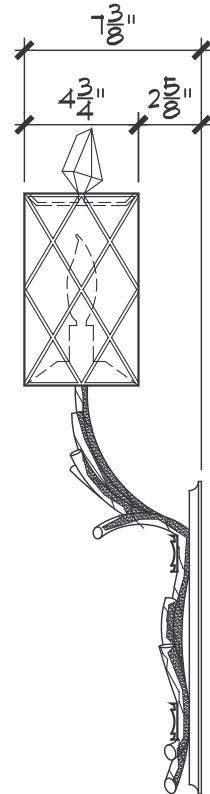

SIDE ELEVATION

DUAL LAMP SCONCE OPTION " B "


2

SCALE: 1-1/2" = 1'-0"


xxxxl.dwg

THIS DESIGN IS THE PROPERTY OF WYNN DESIGN AND DEVELOPMENT, IT MAY NOT BE REPRODUCED, DUPLICATED OR SOLD WITHOUT WRITTEN PERMISSION OF THE OWNER.

DRAWING NUMBER: 2 OF 2	PROJECT NUMBER: TBD	PROJECT: ENCORE CASINO & PUBLIC AREA LIGHTING	680 Pilot Road, suite 1 Las Vegas, Nevada 89119 PHONE: (702) 770-5000 FAX: (702) 770-5003
	REVIEWED BY: DSA	DRAWING TITLE: WALL MOUNTED SCONCE LIGHT	
	DATE: 6-6-2006	CUSTOM DESIGN BY ROGER THOMAS	

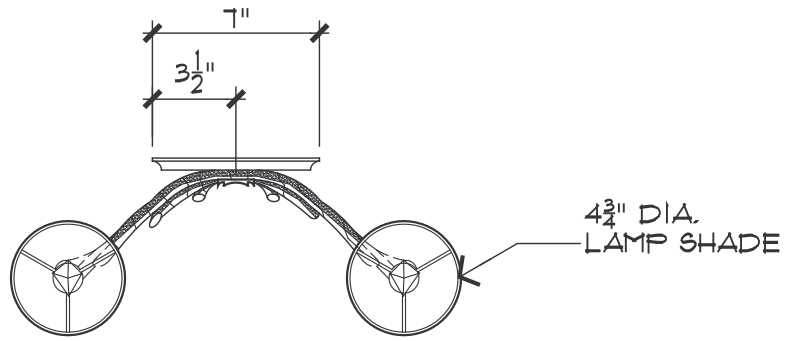

PLAN VIEW

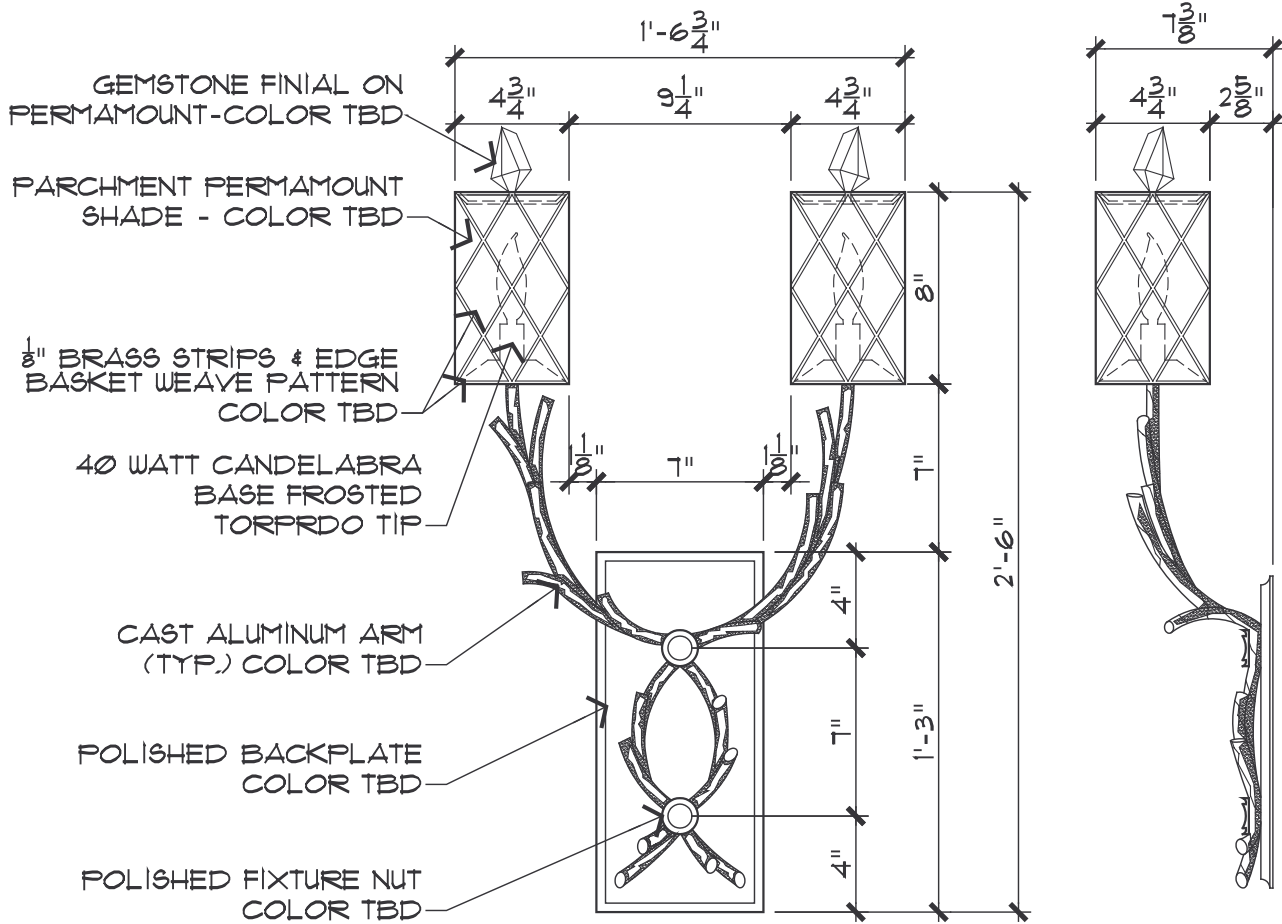

FRONT ELEVATION

SIDE ELEVATION

DUAL LAMP SCONCE CASINO OPTION "A"


1

SCALE: 1-1/2" = 1'-0"


xxxx1.dwg

THIS DESIGN IS THE PROPERTY OF WYNN DESIGN AND DEVELOPMENT, IT MAY NOT BE REPRODUCED, DUPLICATED OR SOLD WITHOUT WRITTEN PERMISSION OF THE OWNER.

DRAWING NUMBER: 1 OF 2	PROJECT NUMBER: TBD	PROJECT: ENCORE CASINO & PUBLIC AREA LIGHTING	680 Pilot Road, suite 1 Las Vegas, Nevada 89119 PHONE: (702) 770-5000 FAX: (702) 770-5003
	REVIEWED BY: DSA	DRAWING TITLE: WALL MOUNTED SCONCE LIGHT	
	DATE: 6-6-2006	CUSTOM DESIGN BY ROGER THOMAS	

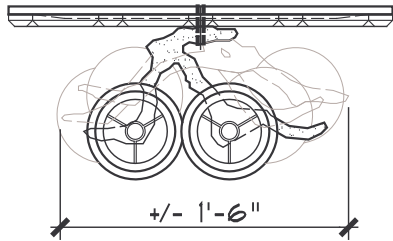

TOP

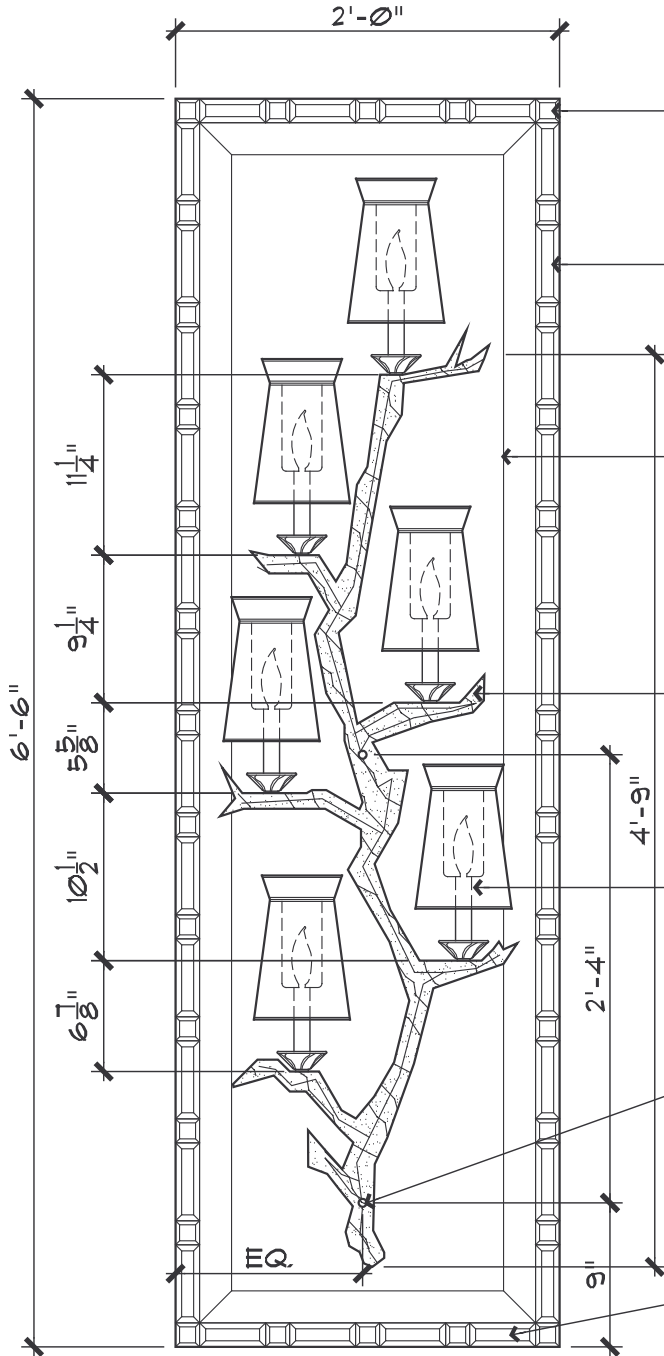

FRONT

1- $\frac{1}{2}$ "Wx1- $\frac{1}{2}$ "Lx $\frac{3}{4}$ "THK.
BEVELED MIRROR PIECES
MEDIUM ANTIQUE FINISH
W/ $\frac{3}{8}$ " BEVEL (TYP.)

1- $\frac{1}{2}$ "Wx4- $\frac{7}{8}$ "Lx $\frac{3}{4}$ "THK.
BEVELED MIRROR PIECES
MEDIUM ANTIQUE FINISH
W/ $\frac{3}{8}$ " BEVEL (TYP. @
SIDES OF MIRROR)

$\frac{3}{4}$ " THICK BEVELED
MIRROR - MEDIUM
ANTIQUÉ FINISH
W/ 2"Wx $\frac{1}{4}$ "THK. BEVEL
- MOUNTING TBD


GILDED/ CAST BRONZE
TREE SCENCE FRAME
ROUTE OUT CHASE FOR
WIRING - FINISH TBD

CUSTOM CANDELABRA
LAMP (TYP. OF 6)

SCENCE MOUNTING TBD -
SHALL BE THROUGH MIRROR
TO WALL & OFFSET W/
STAND OFF STUDS (VERIFY
IN FIELD)

1- $\frac{1}{2}$ "Wx4- $\frac{7}{8}$ "Lx $\frac{3}{4}$ "THK.
BEVELED MIRROR PIECES
MEDIUM ANTIQUÉ FINISH
W/ $\frac{3}{8}$ " BEVEL (TYP. @ TOP
& BOTTOM OF MIRROR)

4" MIN. - 6" MAX.

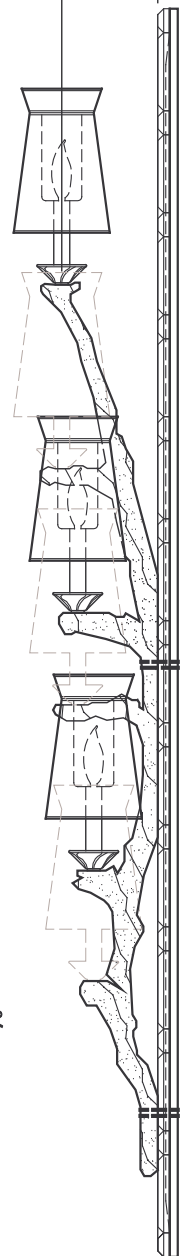

SIDE


THIS DESIGN IS THE PROPERTY OF WYNN DESIGN AND DEVELOPMENT, IT MAY NOT BE REPRODUCED, DUPLICATED OR SOLD WITHOUT WRITTEN PERMISSION OF THE OWNER.

DRAWING NUMBER:
1 OF 2


PROJECT NUMBER:
TBD
REVIEWED BY:
DSA
DATE:
6-6-2006

PROJECT:
ENCORE MEETING ROOM LIGHTING
DRAWING TITLE:
WALL MOUNTED MIRROR & TREE SCENCE LIGHT
CUSTOM DESIGN BY ROGER THOMAS - SCALE: 1" = 1'-0"

680 Pilot Road, suite 1
Las Vegas, Nevada 89119
PHONE: (702) 770-5000
FAX: (702) 770-5003

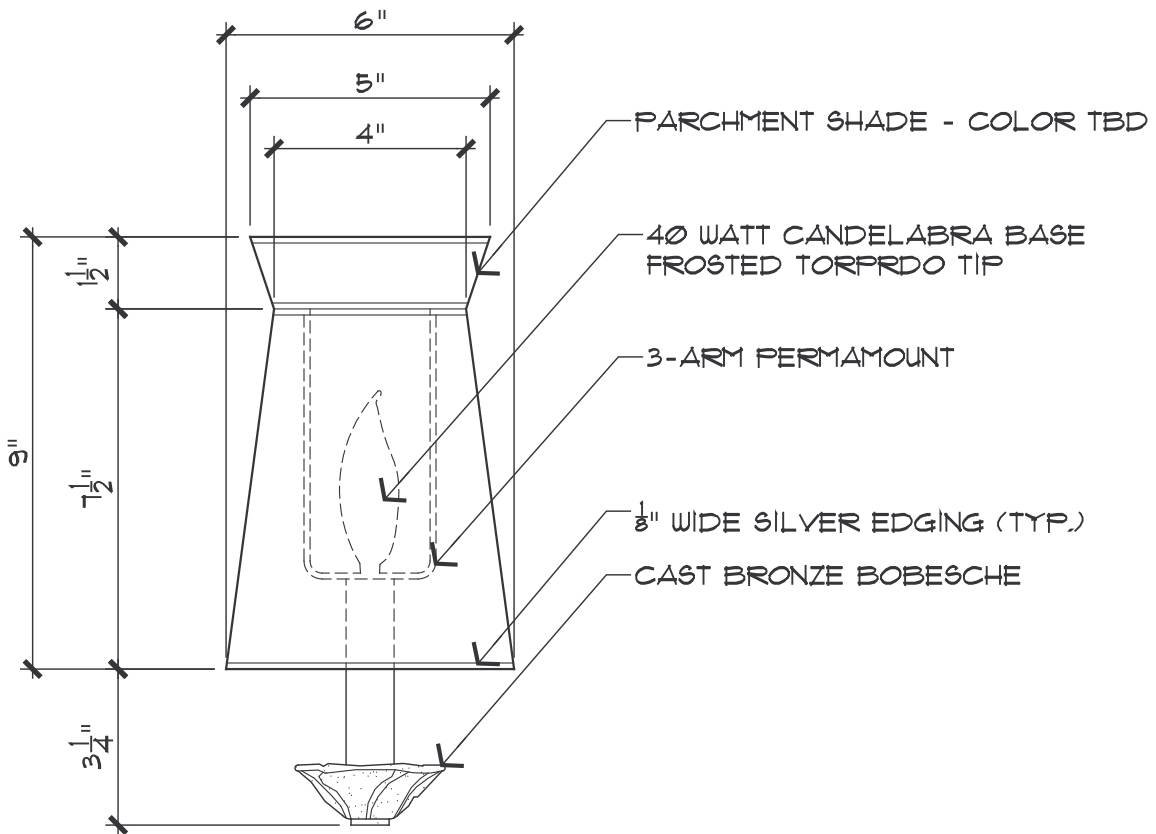

LAMP DETAIL

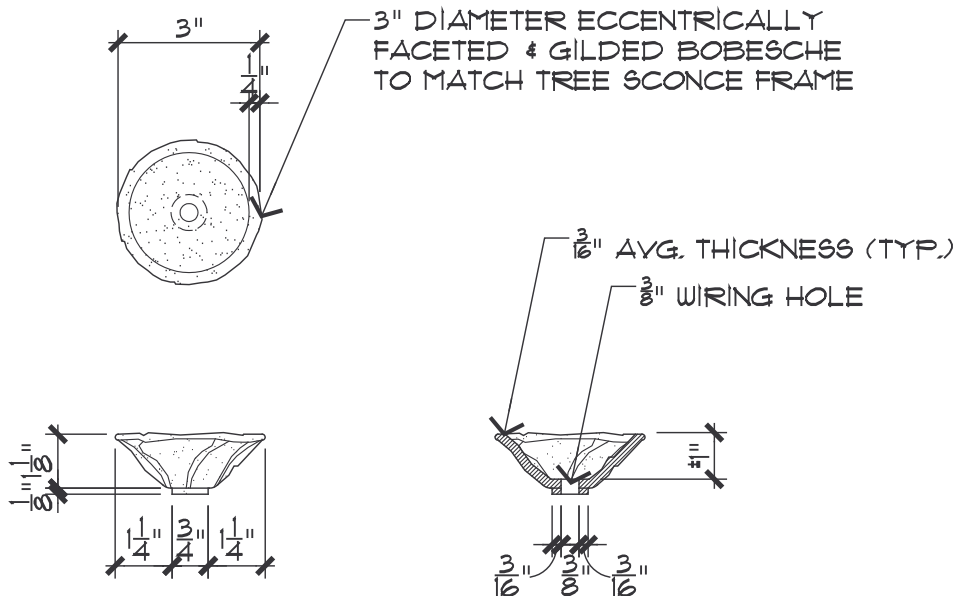

BOBESCHE DETAIL

THIS DESIGN IS THE PROPERTY OF WYNN DESIGN AND DEVELOPMENT, IT MAY NOT BE REPRODUCED, DUPLICATED OR SOLD WITHOUT WRITTEN PERMISSION OF THE OWNER.

DRAWING NUMBER: 2 OF 2	PROJECT NUMBER: TBD REVIEWED BY: DSA DATE: 6-6-2006	PROJECT: ENCORE MEETING ROOM LIGHTING DRAWING TITLE: WALL MOUNTED MIRROR & TREE SCENCE LIGHT CUSTOM DESIGN BY ROGER THOMAS - SCALE: 1" = 1'-0"	680 Pilot Road, suite 1 Las Vegas, Nevada 89119 PHONE: (702) 770-5000 FAX: (702) 770-5003
---------------------------	--	--	--