



BACKPLATE ELEVATION


3/8" CONCAVE BEVEL  
ON BACKPLATE (TYP.)

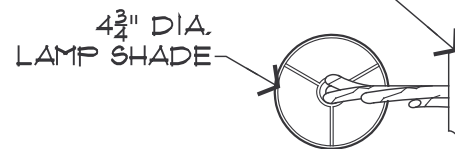

PLAN VIEW

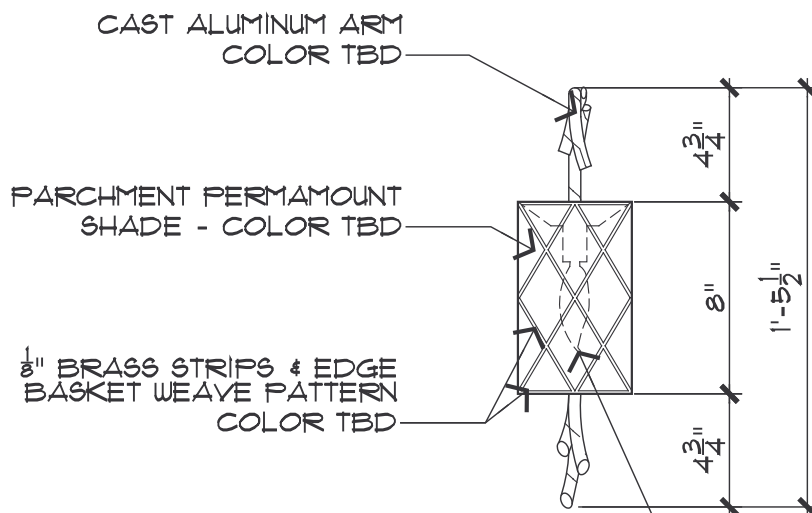

FRONT ELEVATION

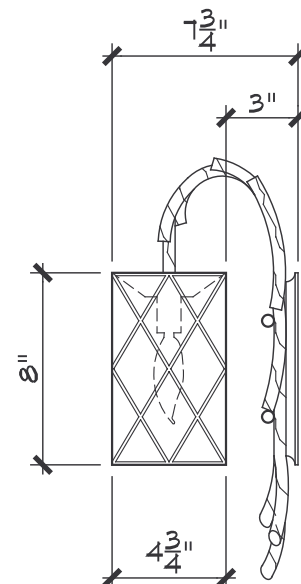

SIDE ELEVATION

40 WATT CANDELABRA BASE  
FROSTED TORPRDO TIP

## 2 LARGE WALL SCONCE

SCALE: 1-1/2" = 1'-0"

xxx1.dwg

THIS DESIGN IS THE PROPERTY OF WYNN DESIGN AND DEVELOPMENT, IT MAY NOT BE REPRODUCED, DUPLICATED OR SOLD WITHOUT WRITTEN PERMISSION OF THE OWNER.

DRAWING NUMBER:  
2 OF 2

PROJECT NUMBER:  
TBD  
REVIEWED BY:  
DSA  
DATE:  
6-6-2006

PROJECT:  
ENCORE PHONE BOOTH LIGHTING  
DRAWING TITLE:  
WALL MOUNTED SCONCE LIGHT  
CUSTOM DESIGN BY ROGER THOMAS



680 Pilot Road, suite 1  
Las Vegas, Nevada 89119  
PHONE: (702) 770-5000  
FAX: (702) 770-5003