



PLAN VIEW

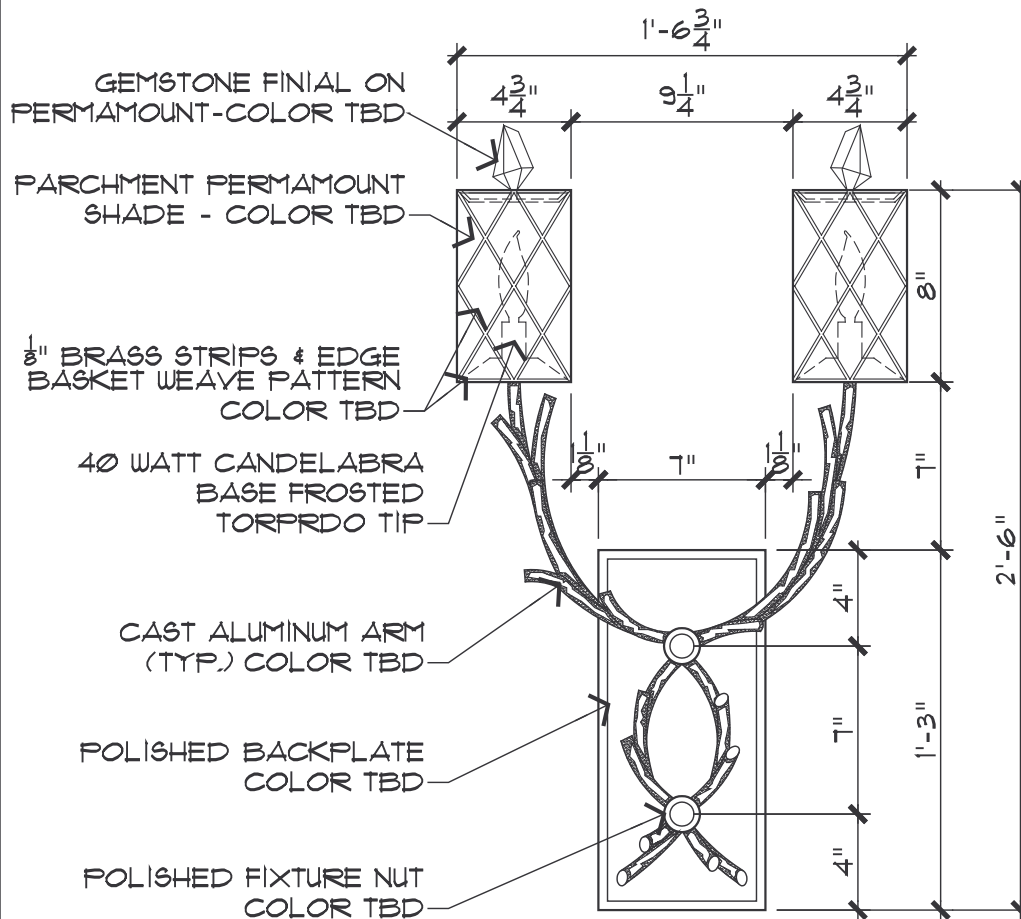

FRONT ELEVATION

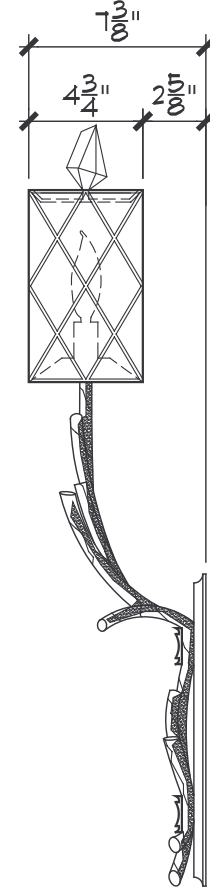

SIDE ELEVATION

# **DUAL LAMP SCONCE** **CASINO OPTION "A"**

SCALE: 1-1/2" = 1'-0"

xxxx.dwg

THIS DESIGN IS THE PROPERTY OF WYNN DESIGN AND DEVELOPMENT. IT MAY NOT BE REPRODUCED, DUPLICATED OR SOLD WITHOUT WRITTEN PERMISSION OF THE OWNER.

|                           |                        |  |  |
|---------------------------|------------------------|--|--|
| DRAWING NUMBER:<br>1 OF 2 | PROJECT NUMBER:<br>TBD | PROJECT:<br>ENCORE CASINO & PUBLIC AREA LIGHTING | 680 Pilot Road, suite 1<br>Las Vegas, Nevada 89119<br>PHONE: (702) 770-5000<br>FAX: (702) 770-5003 |
|                           | REVIEWED BY:<br>DSA    | DRAWING TITLE:<br>WALL MOUNTED SCONCE LIGHT      |  |
|                           | DATE:<br>6-6-2006      | CUSTOM DESIGN BY ROGER THOMAS                    |  |